

Ministerio De Restauracion Ebenezer

BRYAN, TEXAS

SEPTEMBER 2025

Ministerio De Restauracion Ebenezer
C/O Enrique Saldana
5301 North Texas Avenue
Bryan, Tx 77803
979-778-1524

ENGINEER:
MITCHELL & MORGAN, L.L.P.
3204 EARL RUDDER FWY S.
COLLEGE STATION, TEXAS 77845
(979) 260-6963

For Interim Review Only
These documents are not
intended for construction,
bidding, or permit purposes.
Prepared by:
Joel J. Mitchell, P.E.
No. 80649





VICINITY MAP


INDEX OF SHEETS

SP	Site Plan
GP	Grading Plan
PP	Paving Plan
WL	Water Line P&P
UP	Utility Plan
LP	Landscape Plan
IP	Irrigation Plan
ETS	Embedment & Trench Safety
D1	B/CS Std Miscellaneous Details
D2	B/CS Std Miscellaneous Details
D3	B/CS Std Water & Sewer Details


PROJECT BENCHMARK: 60 D Nail between front parking lot and Texas Avenue (50' south of dumpster.) Elev. 343.52

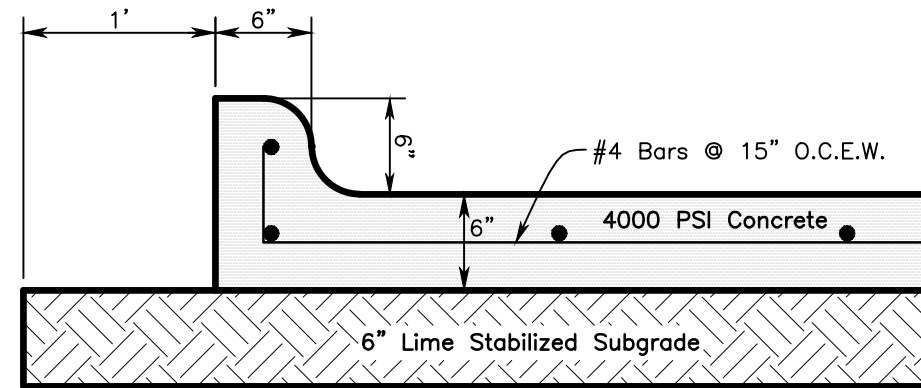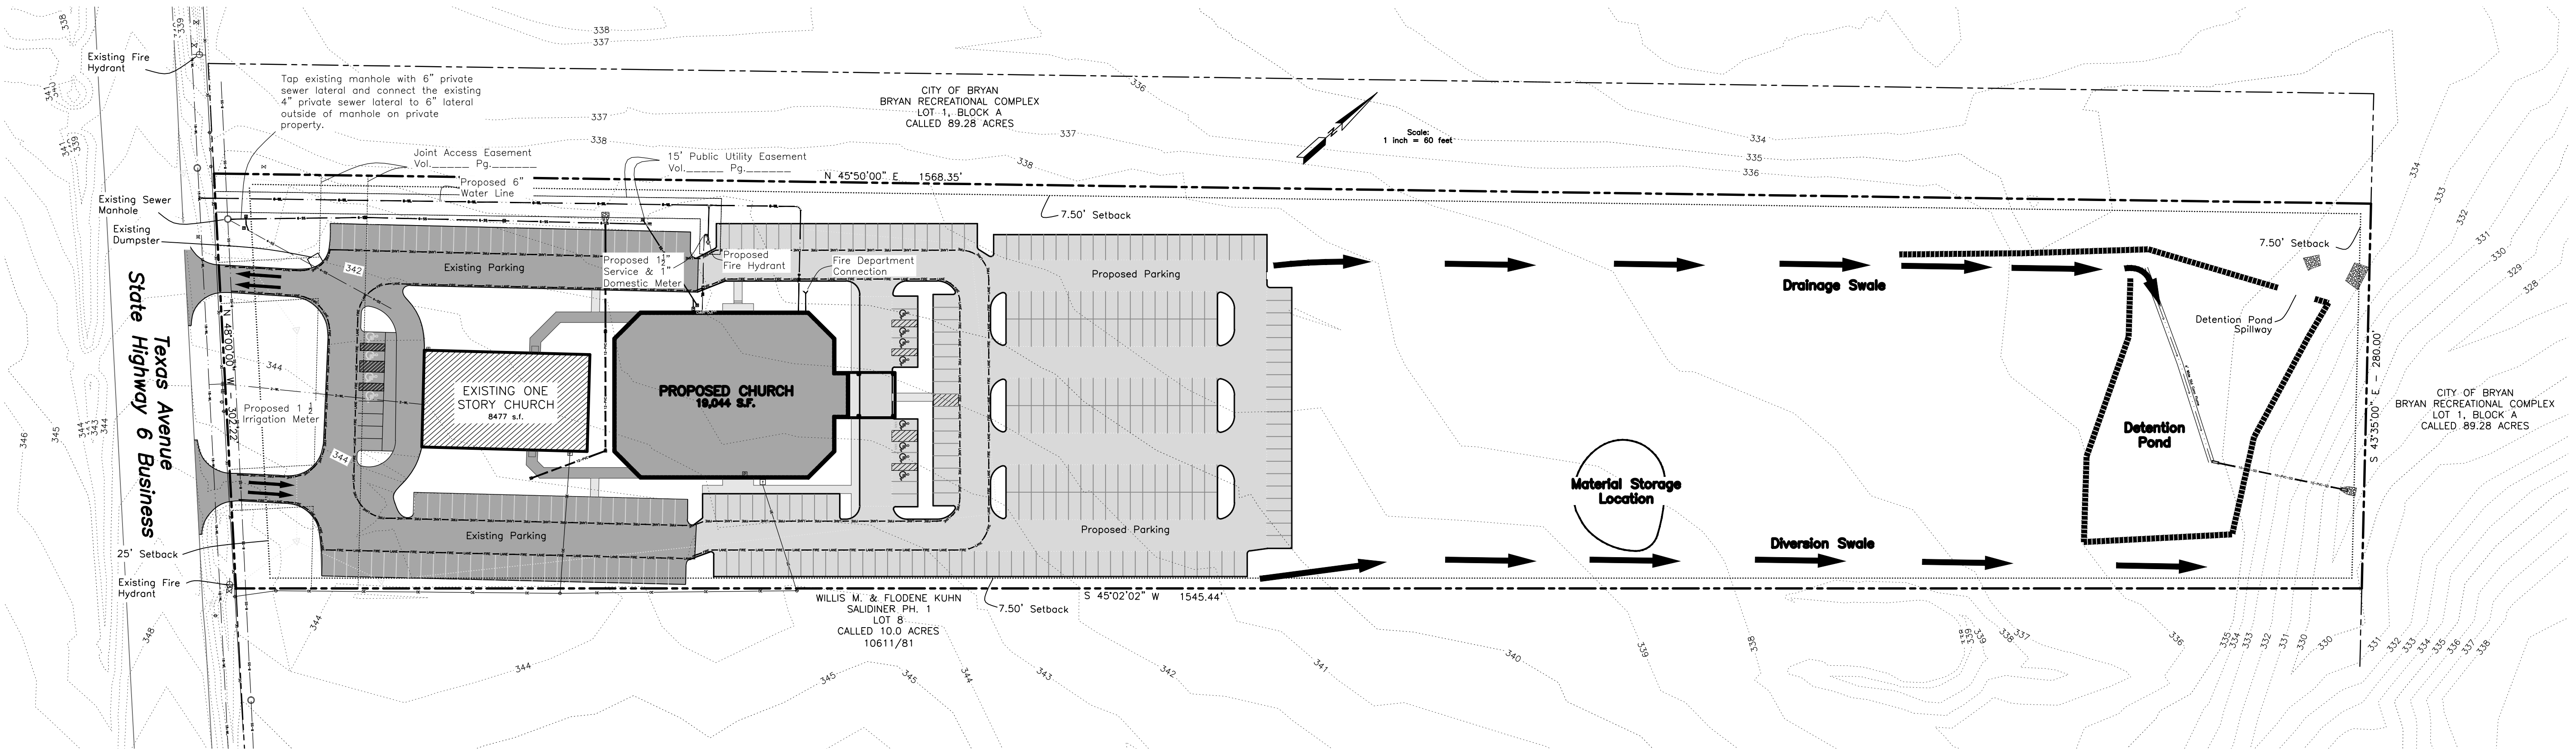

STANDARD CONCRETE PAVEMENT DETAIL
NTS

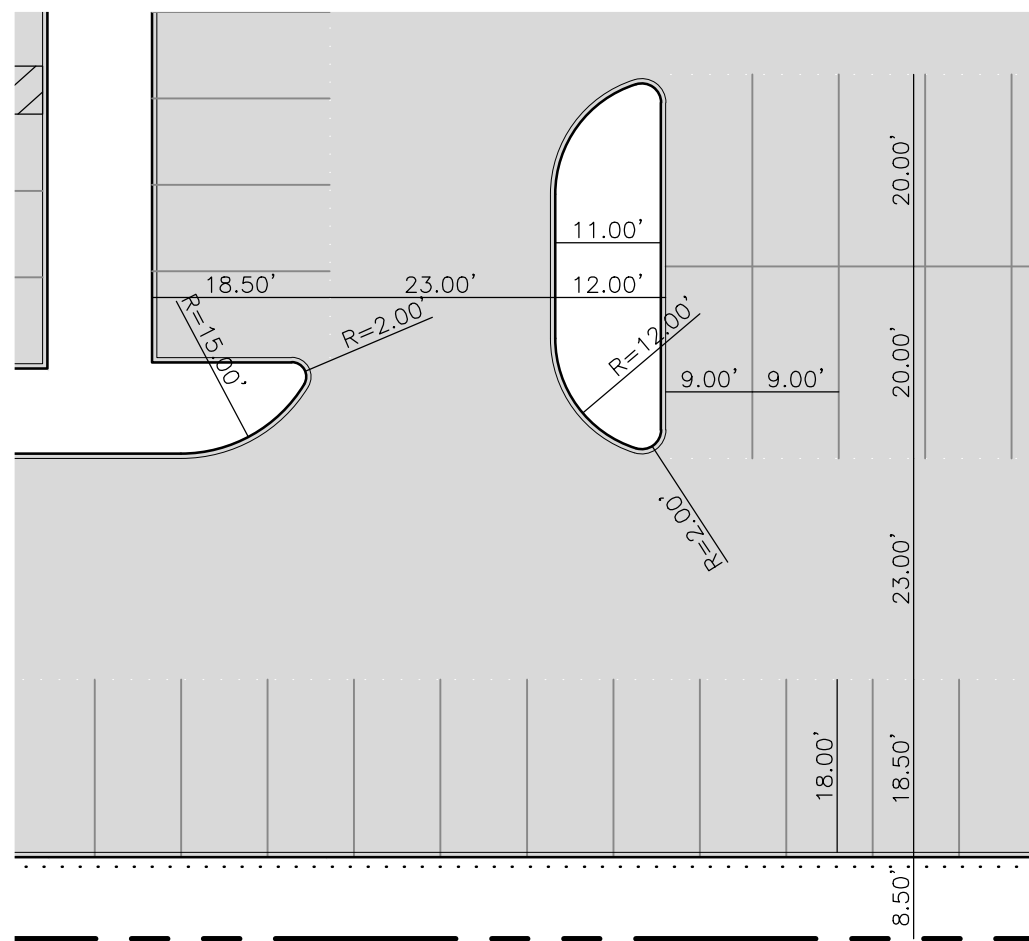

Typ. Parking Space Dimensions

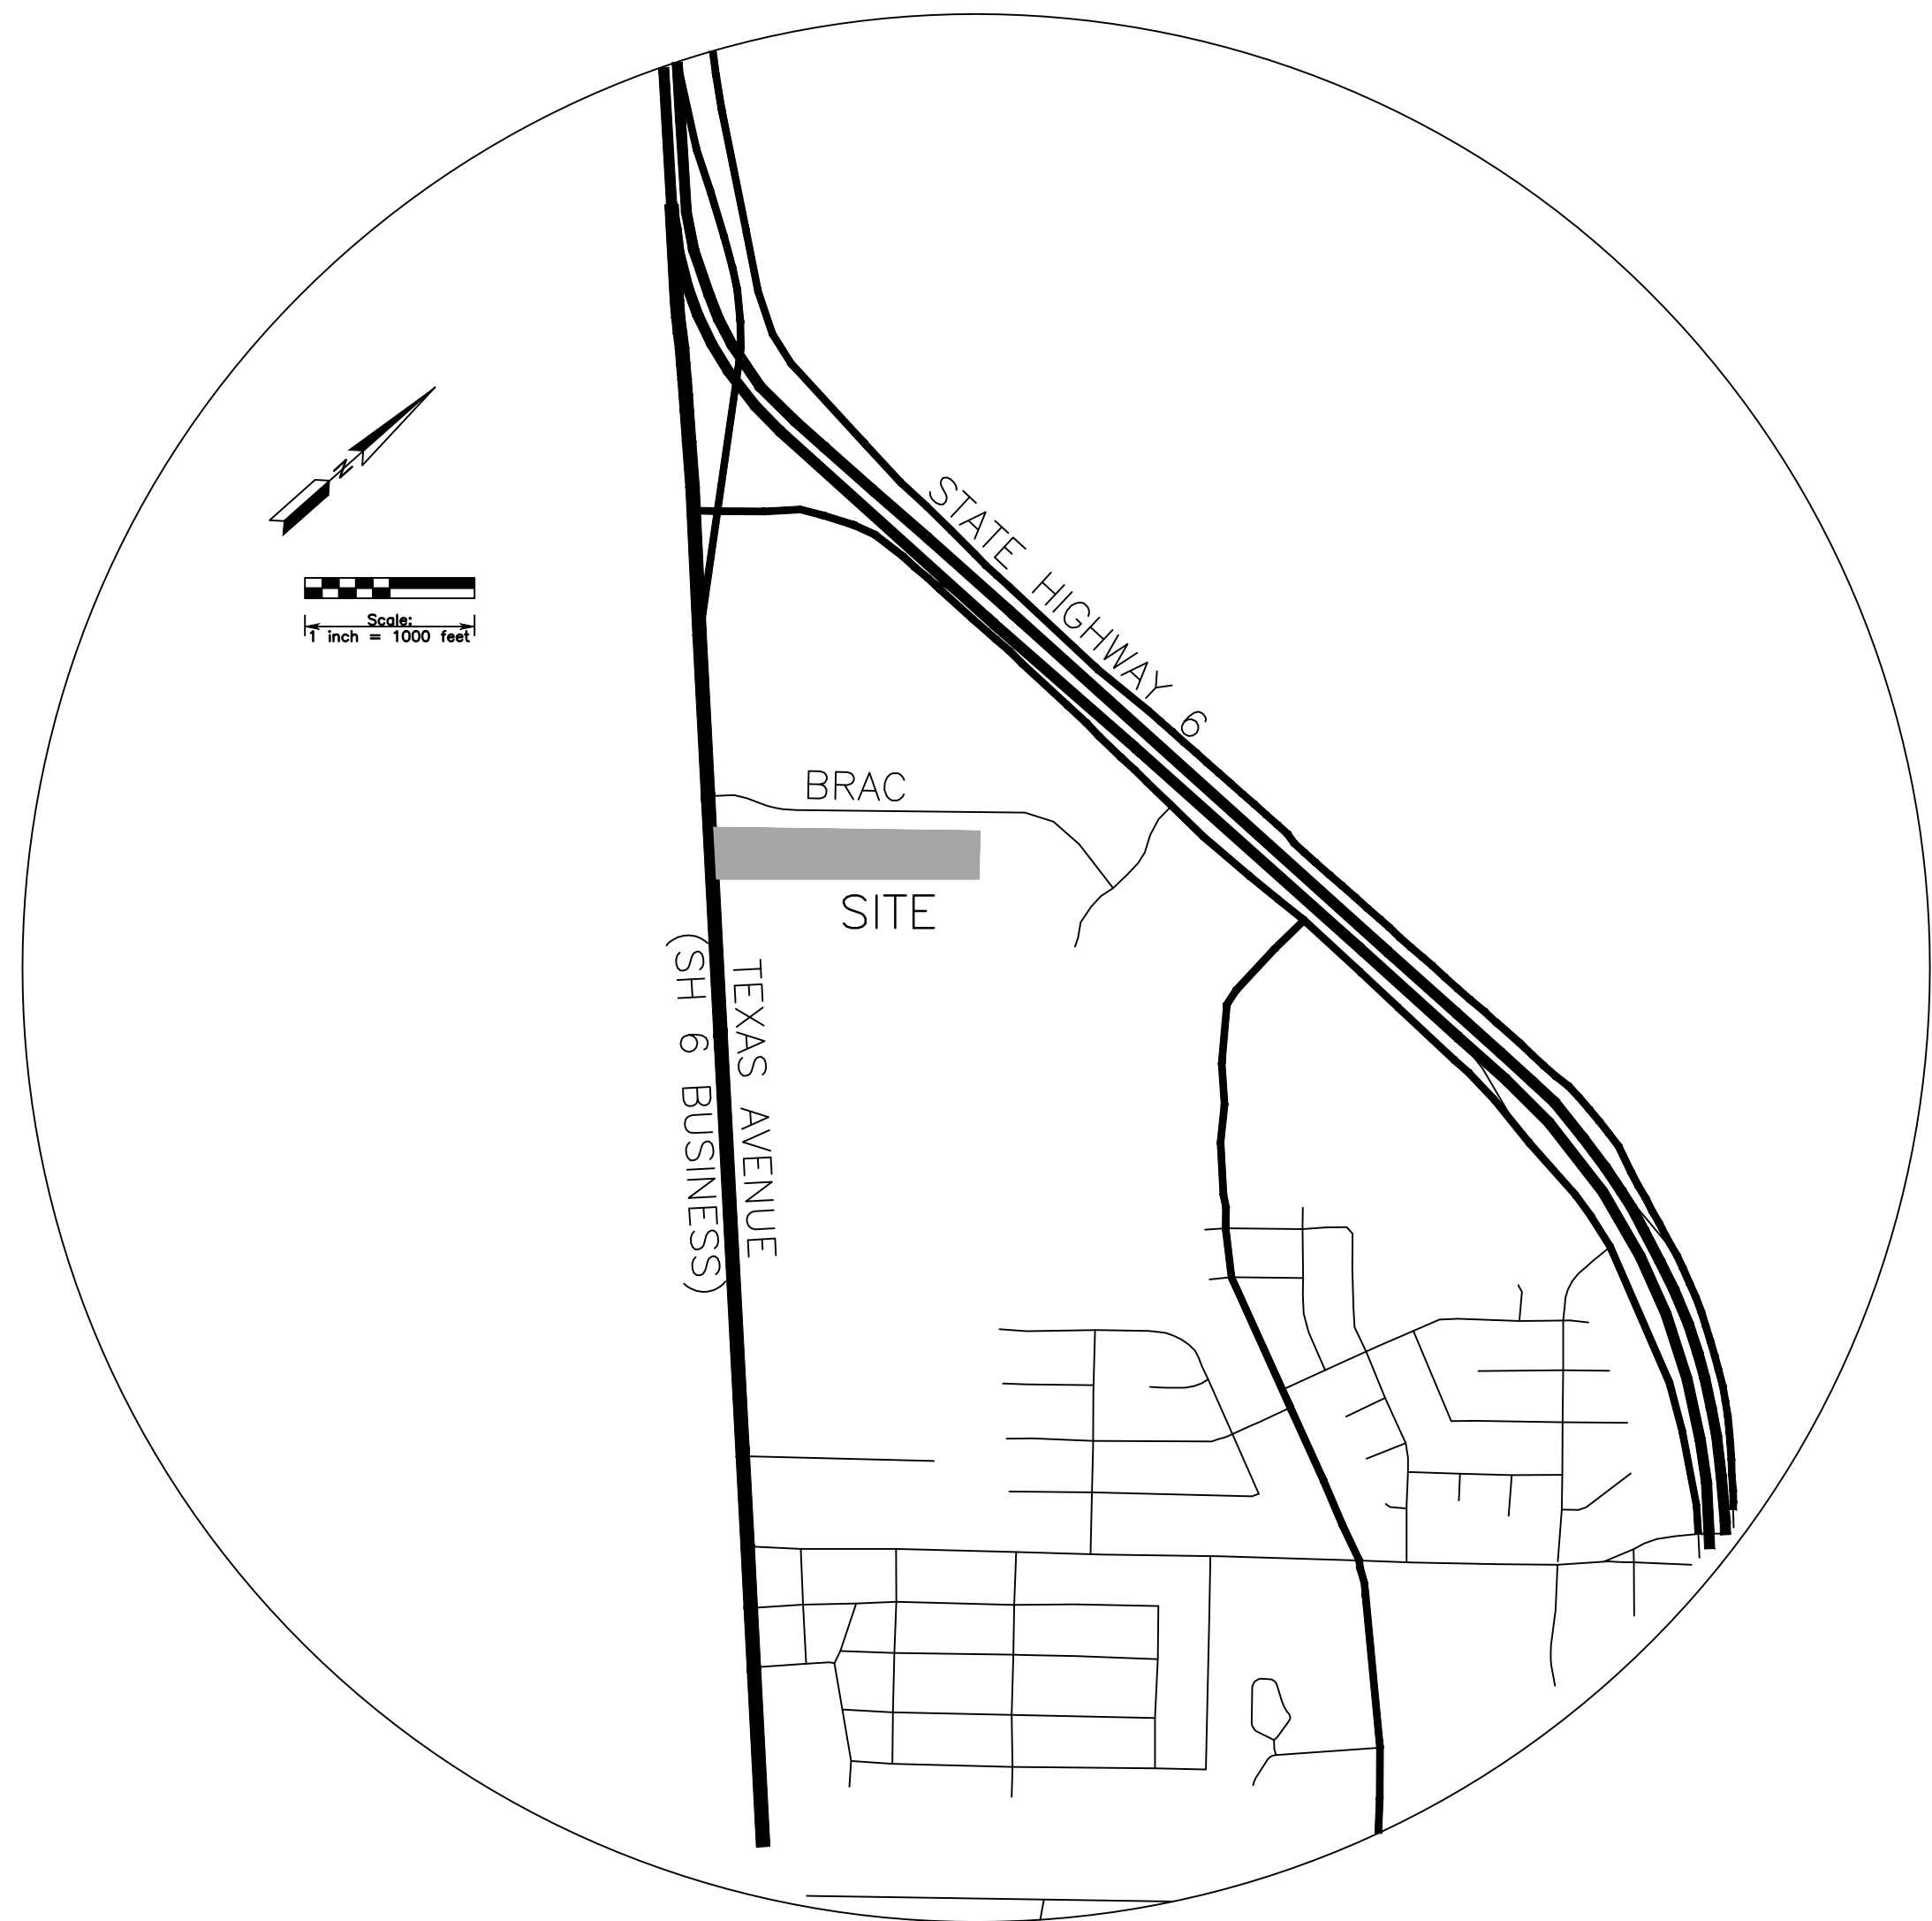

VICINITY MAP

GENERAL CONSTRUCTION NOTES:

- It shall be the responsibility of the Contractor to verify the exact location of ALL existing underground utilities. Furthermore, the Contractor shall contact all utility company representatives a minimum of 48 hours in advance of any excavation.
 - Contact Dig Tess @ 1-800-344-8377
 - Contact Bryan Water Utilities @ 209-5900
 - Contact Luis Cisneros @ ATMOS 286-4939
 - Contact Dan Augsburg @ Optimum 846-2229
 - Contact David Hering @ BTU 821-5770
 - Contact Mitchell Gas @ 779-4460
 - Contact Union Pacific Resources @ 778-8525
 - Contact Richard Wallace @ Verizon 821-4752
- All construction shall be in accordance with the 2012 B/CS Unified Technical Specifications, Water and Sewer and Generals and 2012 B/CS Unified Design Details. All inspection shall be performed by the staff of the City Engineer of Bryan. All construction shall be coordinated with the City of Bryan City Engineer.
- In lieu of using the construction materials indicated in these plans, the Contractor shall obtain written approval from the City Engineer for any substitution prior to Construction. Requests for changes should include product information and an engineer's seal where applicable. The contractor shall be financially responsible for the engineer's time spent reviewing changes and redesigning based on contractors requests.
- Trench Safety Requirements shall be in accordance with O.S.H.A. Standard 29 CFR Part 1926 Subpart P. For general requirements, see Sheet S3 for details.
- TRENCHING AND BACKFILLING: All trenching and backfilling shall conform to the specifications set out herein. Testing shall be provided by a certified laboratory, at the Owner's expense, to verify these standards. Any retesting due to substandard work shall be at the expense of the Contractor. Structural areas shall include all sidewalks and shall extend 5' beyond the curb lines of all streets, alleys and parking areas.
- It is the responsibility of the contractor to comply with all State and Federal Regulations regarding construction activities near energized overhead power lines. Additionally, the contractor shall coordinate all proposed work and procedures with BTU.
- All materials & labor not identified as a Separate Bid Item shall be considered subsidiary to the item in which it is used. All materials and equipment shall be both furnished and installed unless otherwise noted.
- The Contractor must provide construction staking from the information provide on these plans.
- All soil exposed by construction shall receive cellulose fibermulch seeding.
- Trenches may be left open overnight if properly barricaded.
- Adjustment of Water Meters, Valves, Manholes, Irrigation Systems, and any other Public or Private Utility, etc. are not separate pay items. The Price of the adjustment shall be subsidiary to the construction of Sewer Line, Force Main, etc.
- The contractor shall coordinate with Suddenlink Communications, BTU, Atmos Energy, and Verizon to adjust the location of existing facilities.
- The contractor is responsible for traffic control. This is not a separate pay item.
- No spoil areas are available on this site.
- All signage will be permitted separately.
- The Contractor shall be responsible for the containment and proper disposal of all liquid and solid waste associated with this project. The contractor shall use all means necessary to prevent the occurrence of windblown litter from the project site.
- The Contractor shall assure that inspection of all work is completed by the Geotechnical Engineer and/or the owner's representative.
- Demolition/Construction Waste - Site is required to provide containment for waste prior to and during demolition/construction. Solid waste roll off boxes and/or metal dumpsters shall be supplied by City or City permitted contractor(s) only.
- Irrigation System - Potable water supply must be protected by either the atmospheric or pressure vacuum breaker, or testable double check valve assembly, and installed as per City Ordinance.
- Washout area for concrete trucks is provided at the designated "Proposed Staging Area", shown on sheet C6.01, "Staging and Sign Plan".


SITE PLAN NOTES:

- Name of Project: Ministerio De Restauracion Ebenezer
- Project Description: New Sanctuary
- Legal Description: SALDINER PH 1, LOT 9, ACRES 10.6
- Owner: MINISTERIO DE RESTAURACION EBENEZER
- Mailing Address: PENTECOSTAL HOLINESS CHURCH, 205 S PARKER AVE, BRYAN, TX 77803-6927
- Engineer: Mitchell & Morgan, L.L.P., 3204 Earl Rudder Fwy S. College Station, Texas 77845, (979) 260-6963
- Zoning: Single Family 7000
- Existing Use: Church Proposed Use: Church
- Setbacks: Per City of Bryan Ordinances
- Site Area: 10.3941 acres
- Water Demands : 41 gpm by fixture units.
- Sanitary Demands: 41 gpm by fixture units.
- See architectural drawings for all building information.
- The proposed building has no food preparation and cooling facilities.
- This site does not lie within the 100-year floodplain boundary per FEMA's Flood Insurance Rate Map panel 48041C0215F. Effective Date: April 02, 2014.
- Owner shall call BTU Line Design at 821-5770 at least 90 days before power is needed to begin the process for providing power to the area.

Parking:
Required Parking: 1000 seats * 1 space/ 3 seats = 334 spaces.
Provided Parking: 4 existing handicap spaces
84 existing spaces
8 proposed handicap spaces
239 proposed spaces
335 total spaces

See architectural drawings for all building information.
This site does not lie within the 100-year floodplain boundary per FEMA's Flood Insurance Rate Map panel 48041C0215F, Effective Date: April 02, 2014.

Special Notes:
1. Buildings with metal exteriors are prohibited within all residential districts.

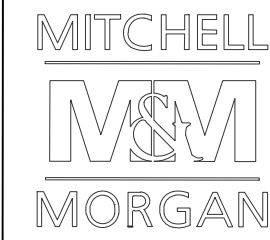

T.979.260.6963
F.979.260.3564
FIRM# 1443
3204 EARL RUDDER FWY S.

COLLEGE STATION, TX 77845

PLAN & DESIGN SPECIALISTS IN
CIVIL ENGINEERING • HYDRAULICS
HYDROLOGY • UTILITIES • STREETS
SITE PLANS • SUBDIVISIONS

www.mitchellandmorgan.com

For Information Only
Not to be used for construction,
or for any other purpose without
the written consent of Mitchell & Morgan,
L.L.P. No. 80649

September 2025
Designed by: JM, MAB
Drawn By: JM, MAB


Prepared For:
Ministerio de Restauracion Ebenezer
C/O Enrique Saldaña
5301 North Texas Avenue
Bryan, TX 77803
979-778-1324

Revisions



Site Plan
Ministerio De Restauracion Ebenezer
BRYAN, TEXAS



PROJECT BENCHMARK: 60 D Nail between front parking lot and Texas Avenue (50' south of dumpster.) Elev. 343.52

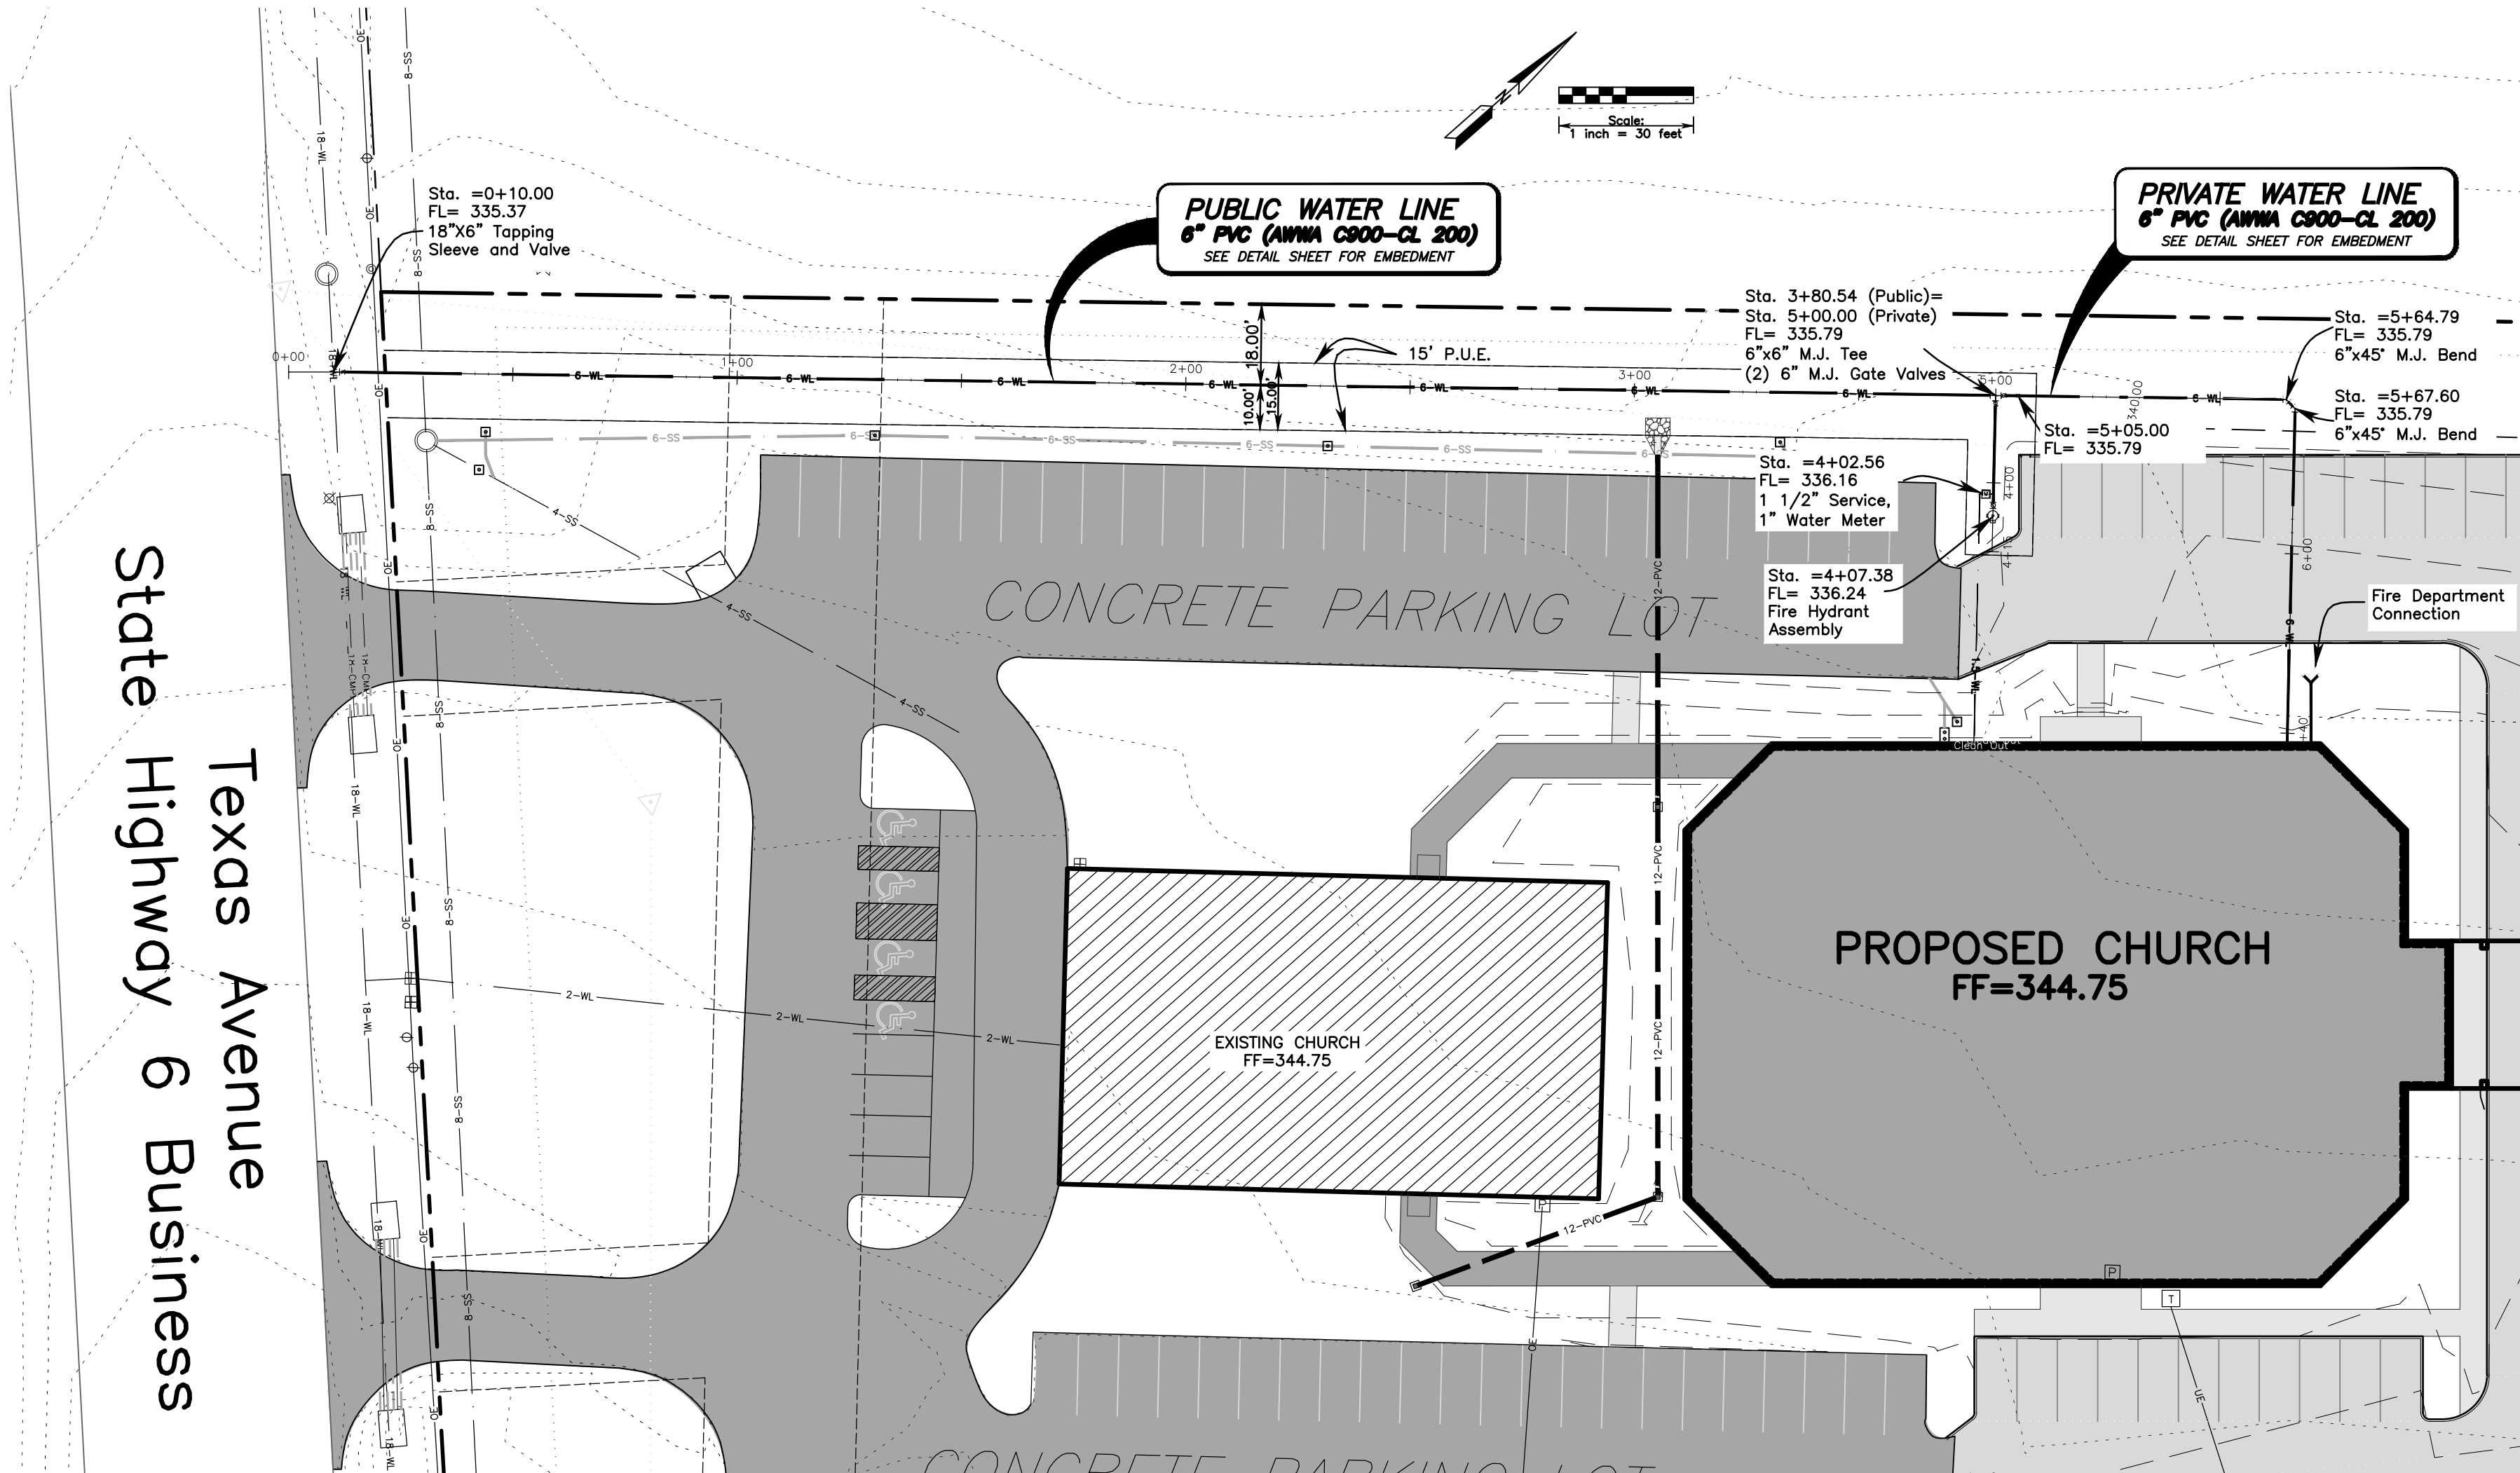

NOTE:
A BACKFLOW PREVENTER/
DOUBLE CHECK VALVE
ASSEMBLY IS PROVIDED
WITHIN THE BUILDING IN THE
FIRE SPRINKLER RISER ROOM.

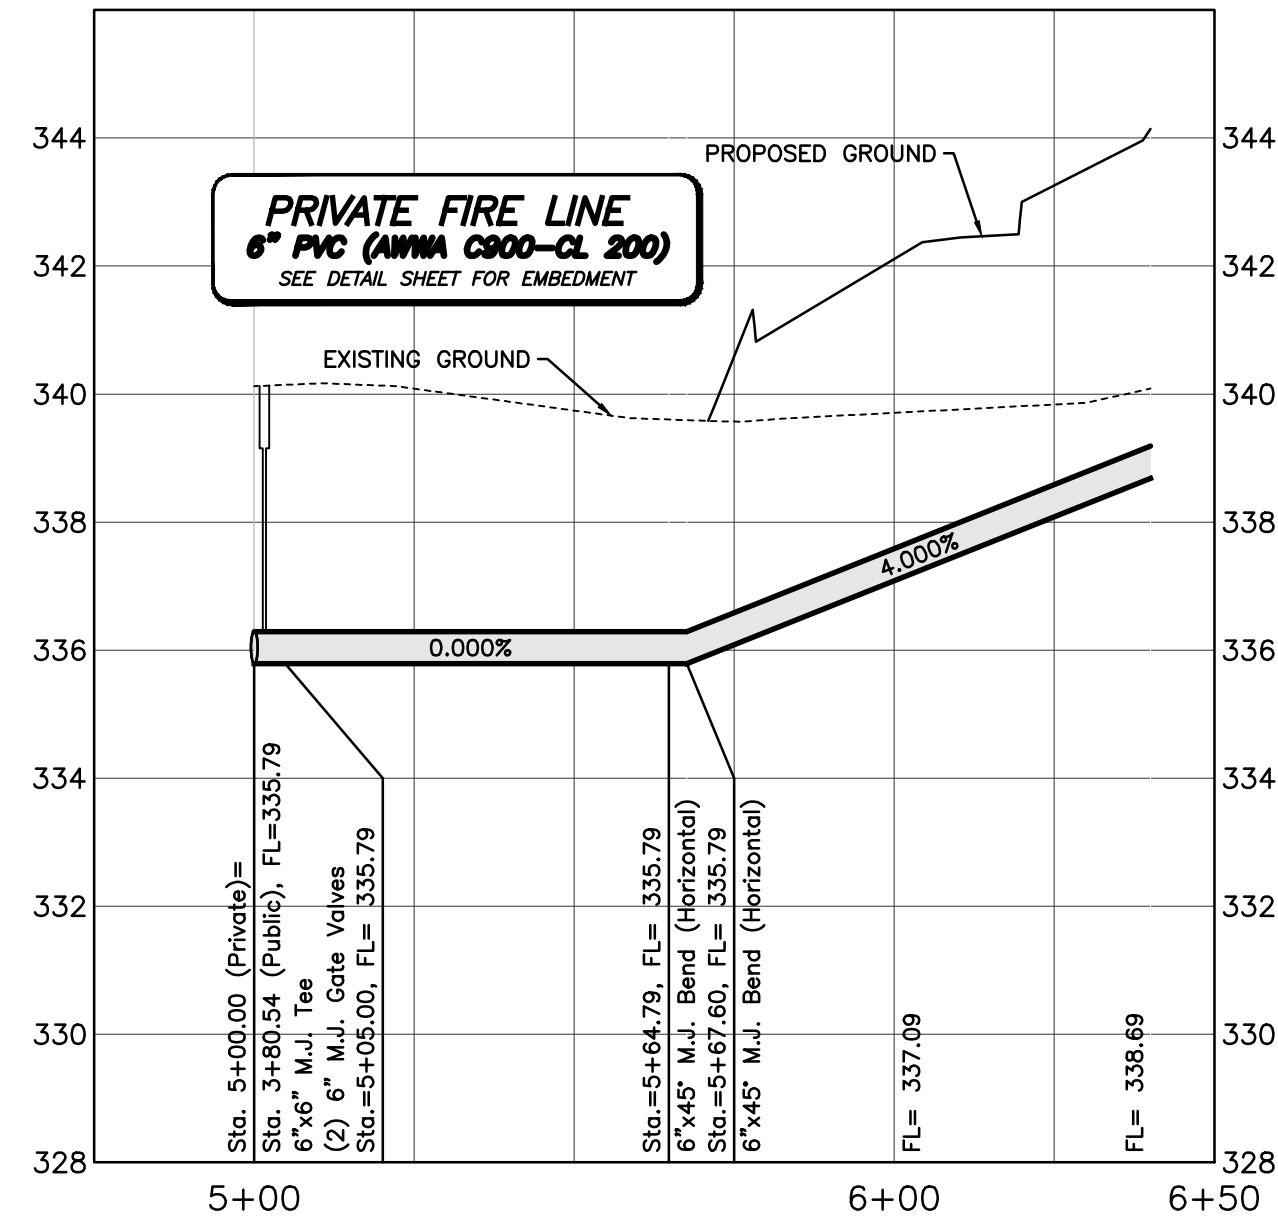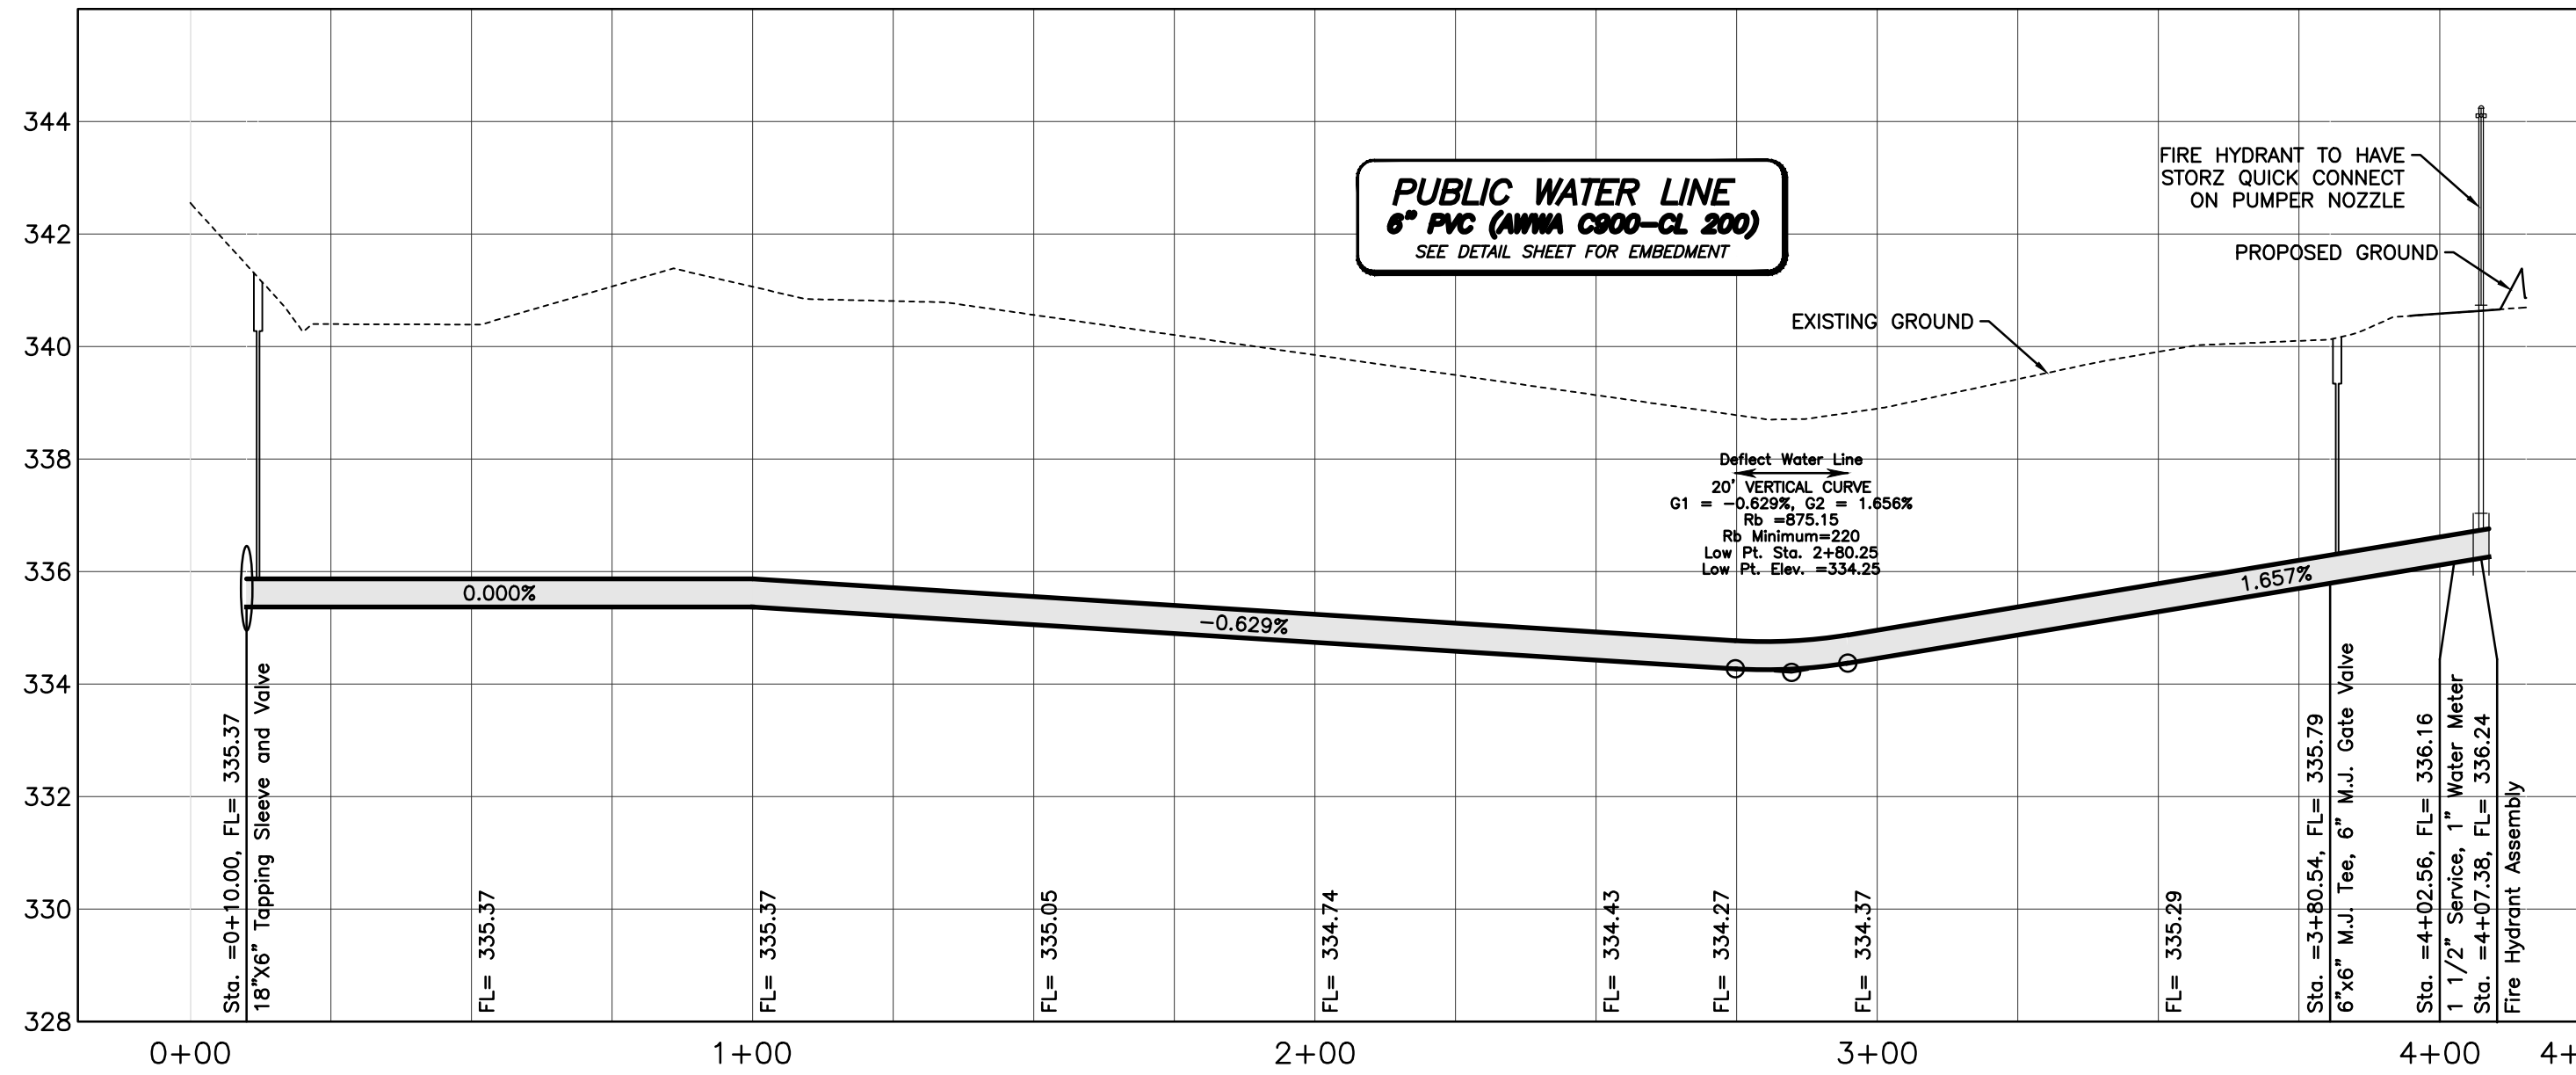

T.979.260.6963
F.979.260.3564
FIRM# 1443
3204 EARL RUDDER FWY S.

COLLEGE STATION, TX 77845

PLAN & DESIGN SPECIALISTS IN
CIVIL ENGINEERING • HYDRAULICS
HYDROLOGY • UTILITIES • STREETS
SITE PLANS • SUBDIVISIONS

www.mitchellandmorgan.com

For information only.
This drawing is not
intended for construction.
It is provided for reference
only. Prepared by: J.M.
Date: 8/26/2025

September 2025
Designed By: JM
Drawn By: JM, MAB

PL 2500-1 102' x 60' - Water Line Map
PLOT 17 2500-1 102' x 60' - Water Line Map


Prepared For:
Ministerio de Restauracion
Ebenezer
C/O Enrique Saldana
5301 North Texas Avenue
Bryan, TX 77803
979-778-1324

Revisions

Water Line P&P
Ministerio De Restauracion Ebenezer
BRYAN, TEXAS


WL

PROJECT BENCHMARK: 60 D Nail between front parking lot and Texas Avenue (50' south of dumpster.) Elev. 343.52

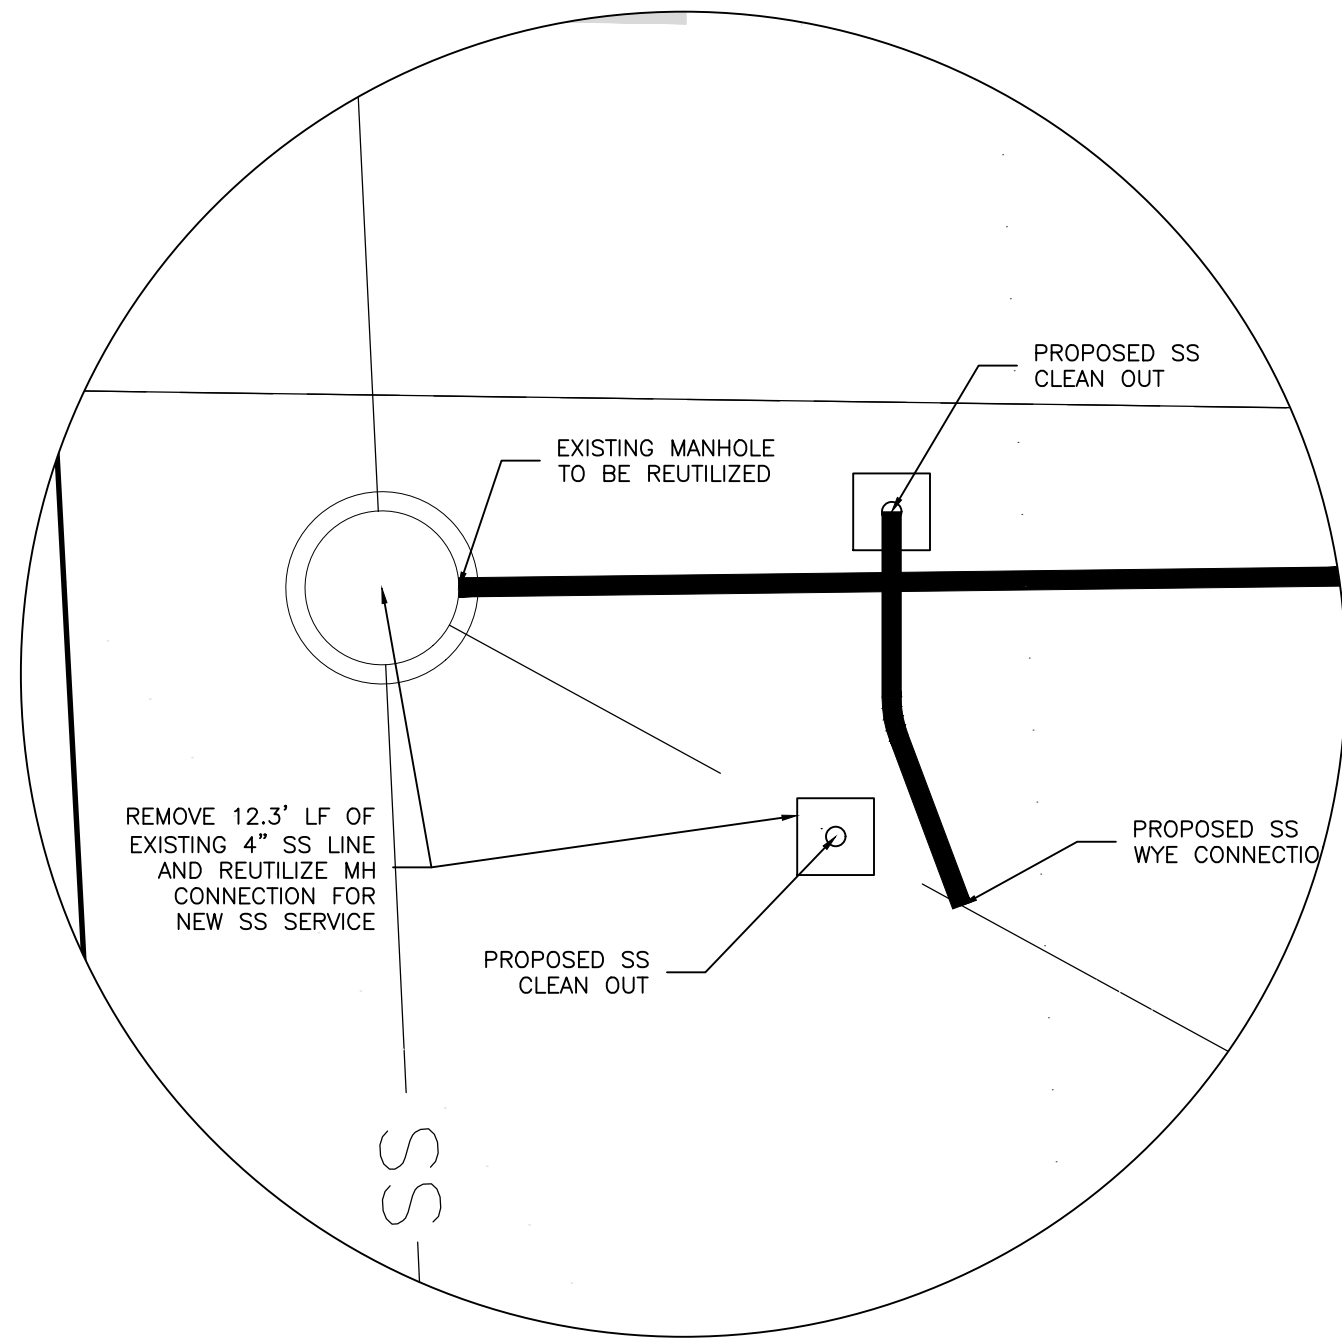

RECONNECTION DETAIL OF EXIST. 6" SS LINE TO NEW 6" SS SERVICE LINE

SCALE: 1" = 5'

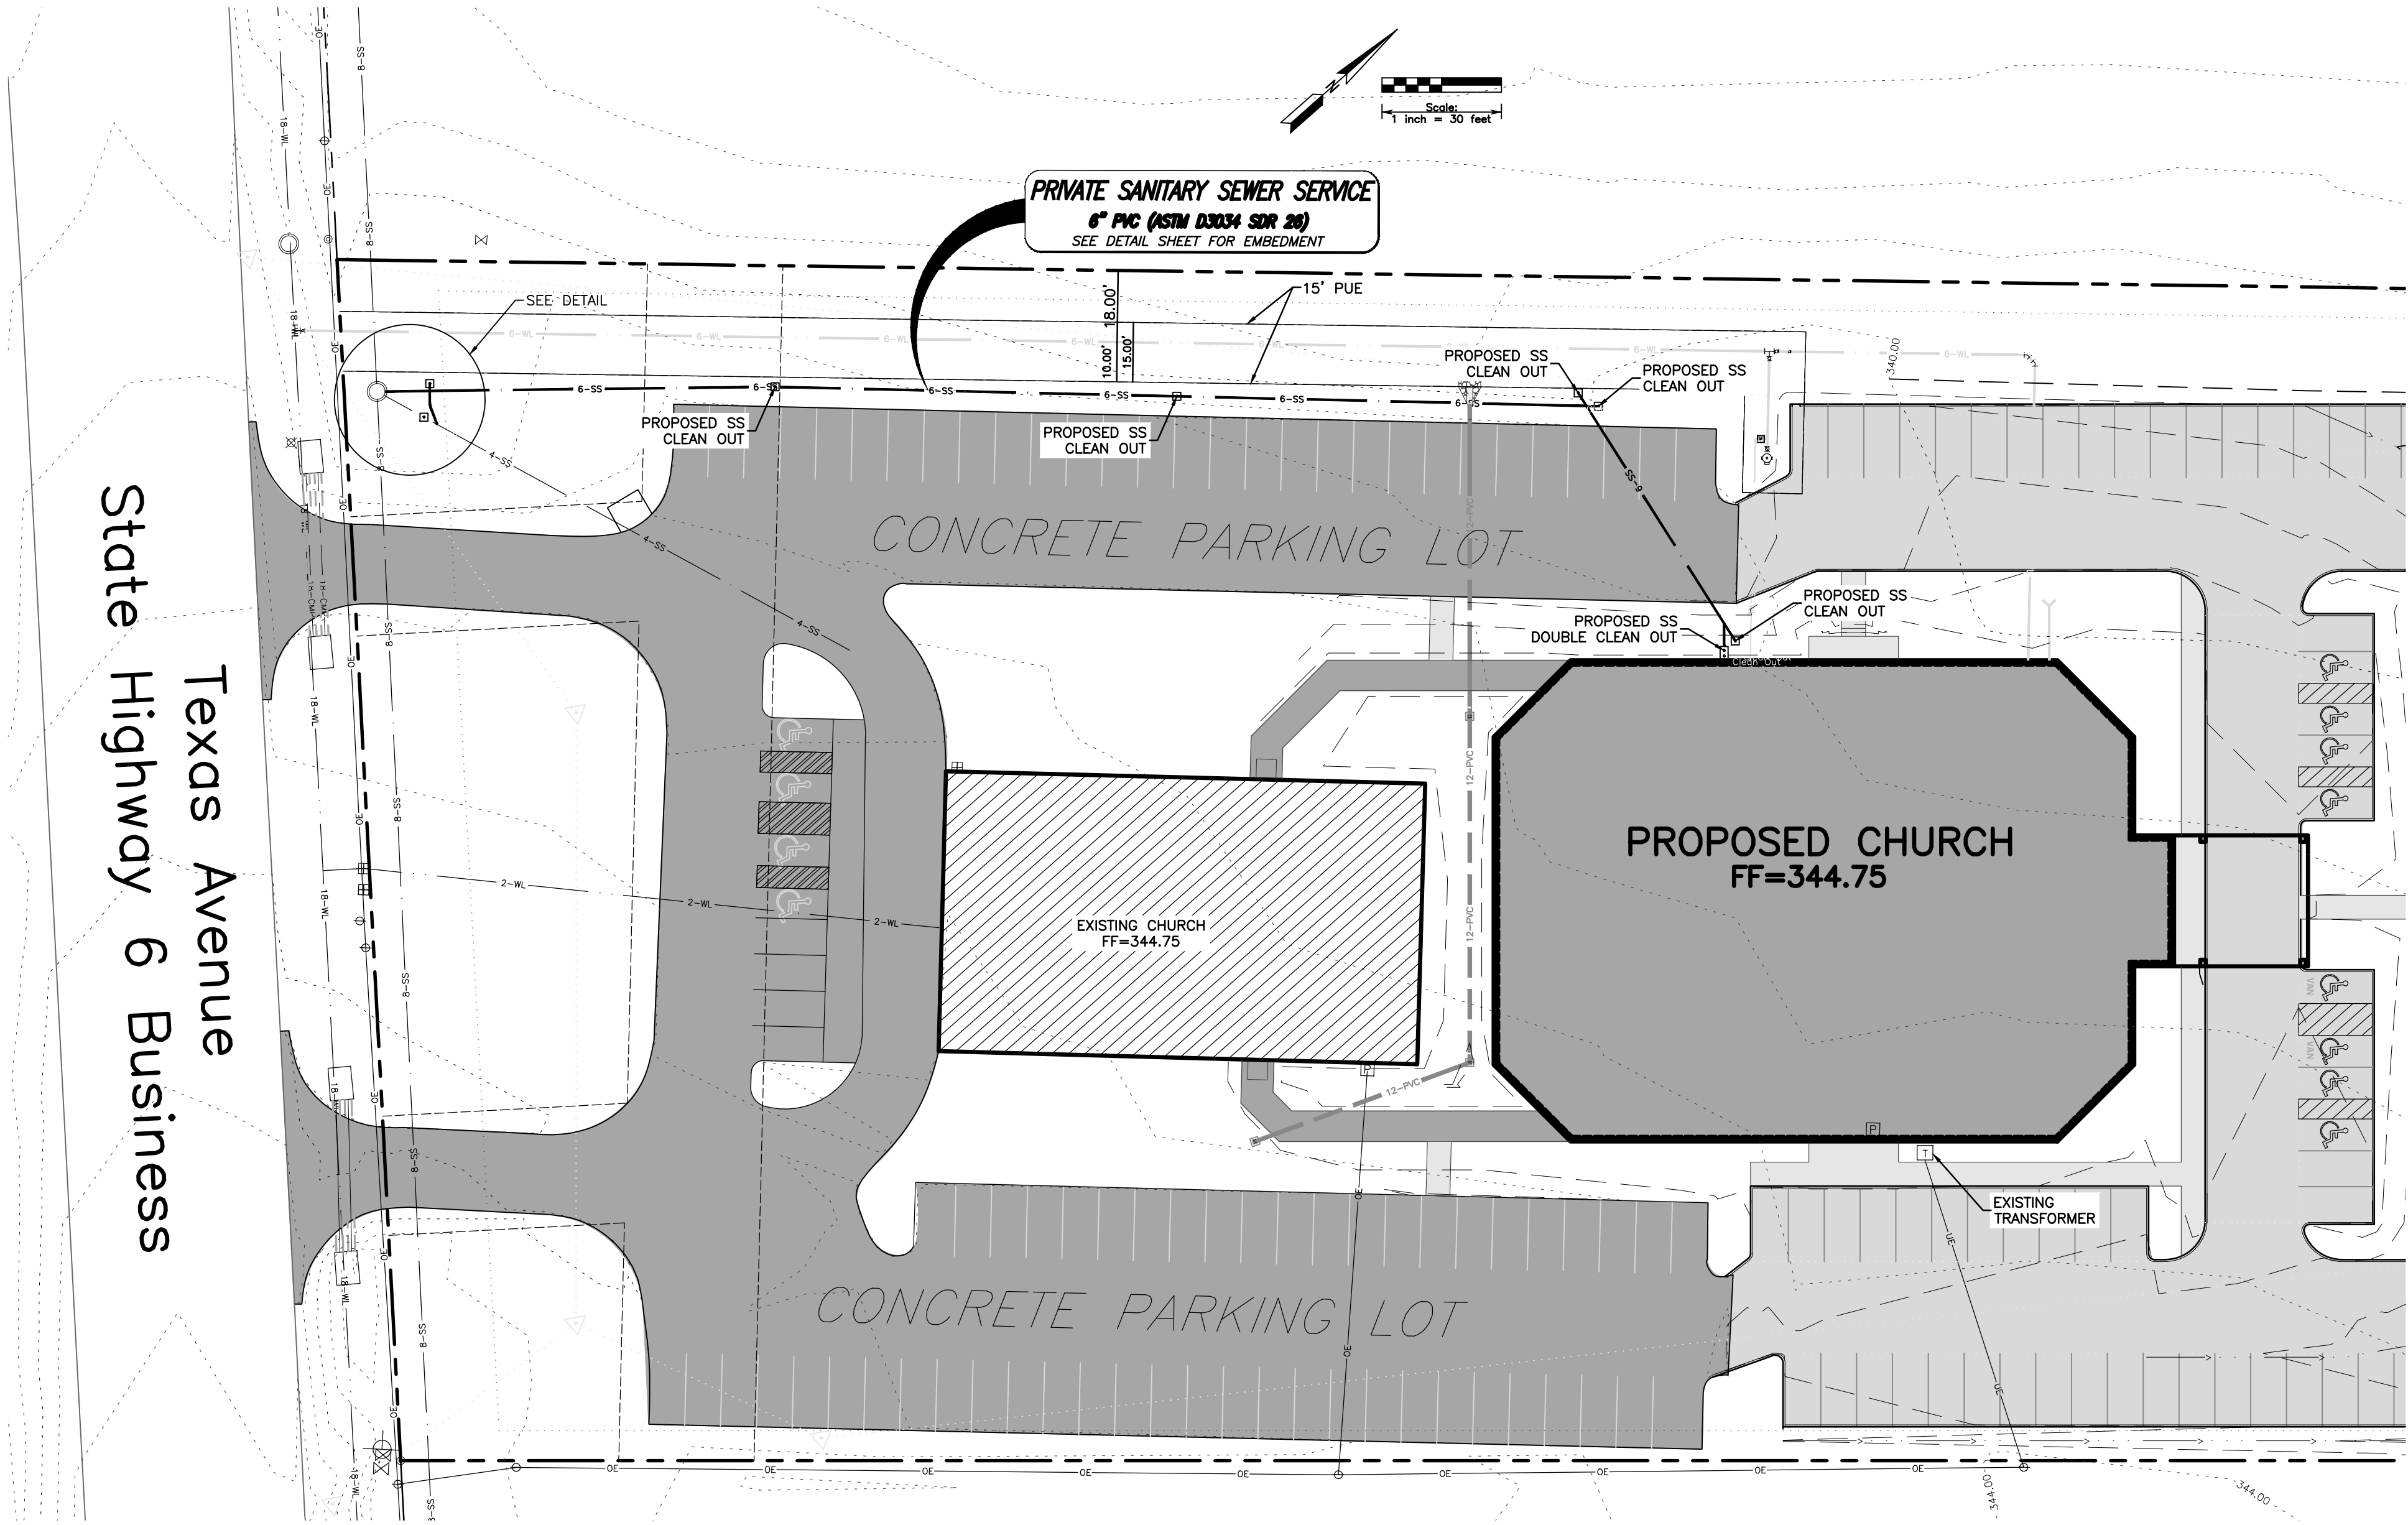

T.979.260.6963
F.979.260.3564
FIRM# 1443
3204 EARL RUDDER FWY S.

COLLEGE STATION, TX 77845

PLAN & DESIGN SPECIALISTS IN
CIVIL ENGINEERING • HYDRAULICS
HYDROLOGY • UTILITIES • STREETS
SITE PLANS • SUBDIVISIONS

www.mitchellandmorgan.com

For Information Only
This drawing was not
prepared for construction,
but for informational purposes
only.
Prepared by: J.M.
Date: 10/1/2025

September 2025
Designed by: JM, MAB
Drawn By: JM, MAB

PLANNED: 10/1/2025
DESIGNED: 10/1/2025
DRAWN: 10/1/2025
CHECKED: 10/1/2025

Prepared For:
Ministerio de Restauracion
Ebenezer
C/O Enrique Saldana
5301 North Texas Avenue
Bryan, TX 77803
979-778-1324

Revisions

Utility Plan
Ministerio De Restauracion Ebenezer
BRYAN, TEXAS


UP

BRYAN REGIONAL ATHLETIC PARK



PLANTER BED SECTION

LP

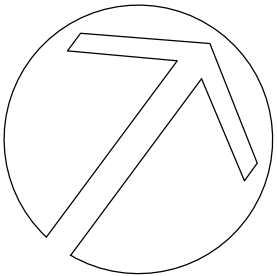

NORTH

SCALE: $1'' = 40'$